
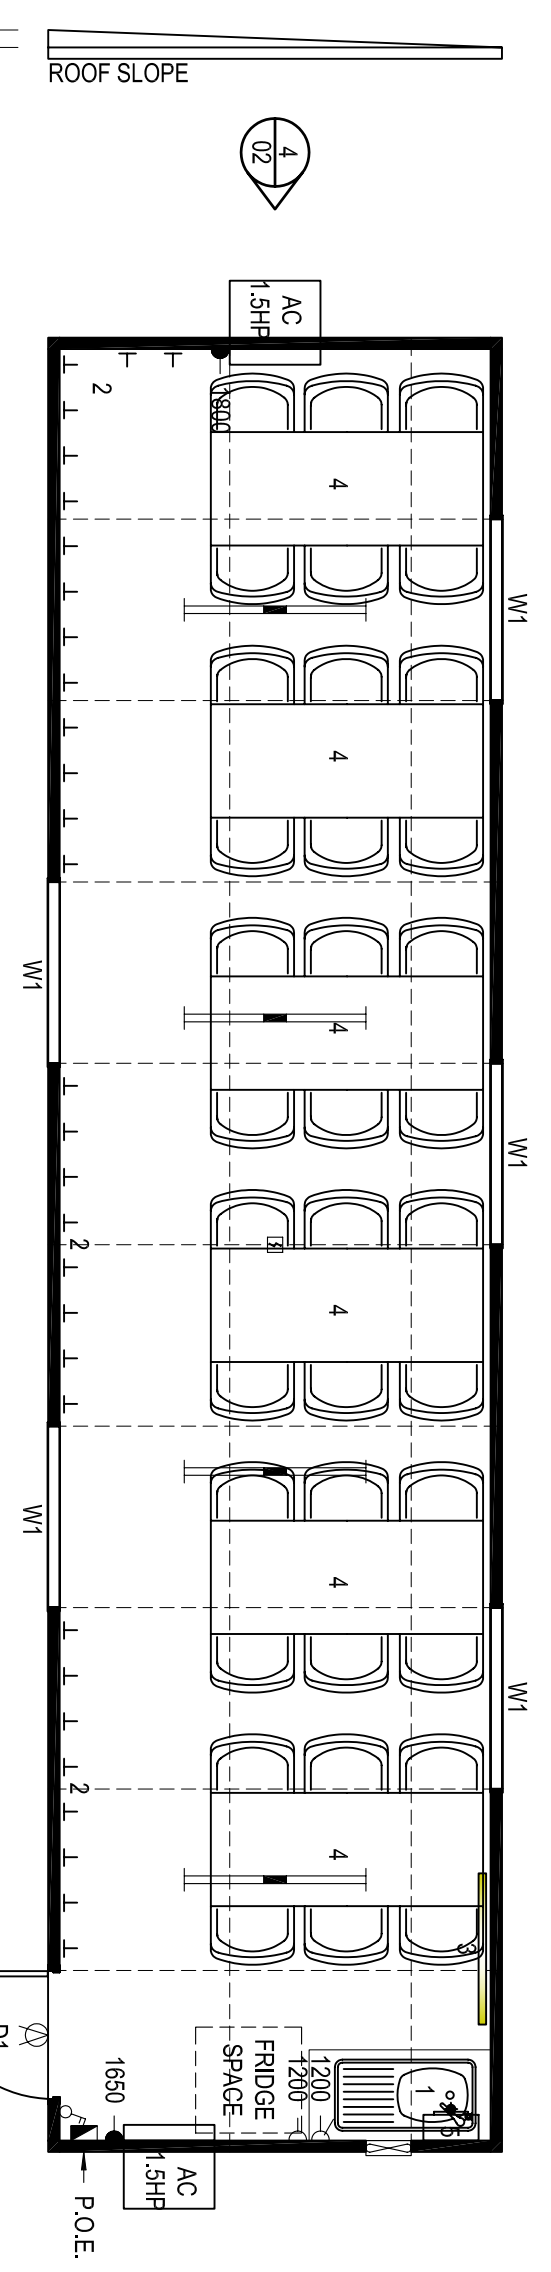


BUILDING DESIGN CRITERIA
 Wind Load - in accordance with AS:1170:22002
 REGION A, TERRAIN CATEGORY 2
 Annual Probability of Exceedance 1:500
 REGIONAL WIND SPEED - V500 = 45 m/s
 Built To: BUILDING CLASS 6

EXTERNAL DIMENSIONS - 12.0m x 3.0m
INTERNAL DIMENSIONS - 11.85m x 2.85m = 33.77m²
EXTERNAL AREA - 36m²
EXTERNAL PERIMETER - 30m
CEILING HEIGHT - 2.4m

FIRE LEGEND		ELECTRICAL LEGEND	
DESCRIPTION	QTY	DESCRIPTION	QTY
<input checked="" type="checkbox"/> SMOKE DETECTOR : HARD WIRED	1	CIRCUIT BREAKER BOARD : (POINT OF ENTRY)	1
<input type="checkbox"/> MISCELLANEOUS	0	SWITCH : LIGHT : DOUBLE	1
		LIGHT : 2x36w FLUORESCENT : DIFFUSED	4
		LIGHT : EXTERNAL BULKHEAD : W/PROOF	1
		GPO : 10 AMP SINGLE : HEIGHT SHOWN	1
		GPO : 10 AMP DOUBLE : HEIGHT SHOWN	1
		GPO : 15 AMP SINGLE : HEIGHT SHOWN	2
		FAN : EXHAUST : WALL MOUNTED	1
		0amps TOTAL BUILDING AMPAGE - SINGLE PHASE	

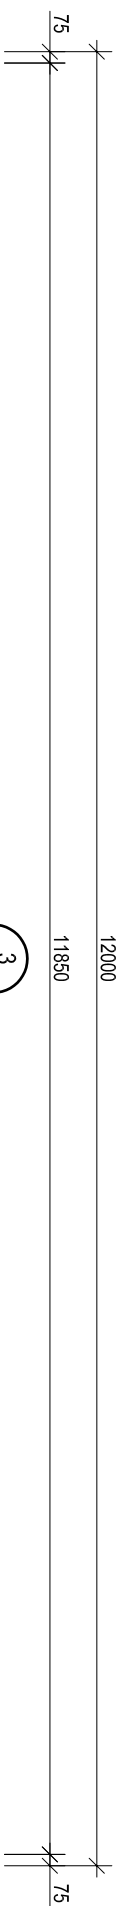

PLAN VIEW
 scale 1:50

No.	DESCRIPTION	QTY
D1	2040h x 820w PLAIN METAL PANEL EXTERNAL DOOR	1
W1	1050h x 1190w HORIZ. SLIDING WINDOW c/w FLYSCREEN	5
AC	WALL MOUNTED REVERSE CYCLE AIR CONDITIONER (1.5HP)	2
1	600 WIDE LAM. BENCH TOP c/w 930 LONG S.S. SINGLE BOWL SINK INSET & CUPBDS UNDER	1
2	COAT HOOK @ 300 CTRS	30
3	1000 x 1200 PIN UP NOTICE BOARD	1
4	1800 x 750 TABLE c/w 6 PVC STACK CHAIRS	6
5	5 LITRE ZIP BOIL	6

EQUIPMENT LIST

PANEL BUILDING SHORT SPECIFICATION REG A

- CHASSIS - STEEL BEAMS c/w GALV. JOISTS 75 x 40 CEE SECTIONS @ MAX 400 CTRS
- FLOORING - 22mm T&G AQUATITE TERMINITE TREATED PARTICLE BOARD
- FLOOR COVERING - 1.5mm VINYL FLOOR FINISH
- EXTERNAL WALLS - 75mm PANEL c/w 0.4mm COLORBOND fixings - refer colour schedule
- ROOF INSULATION - R1.8 POLYESTER INSULATION between ceiling joists with THERMALBREAK under roof sheets - TOTAL ROOF RATING R3.6
- ROOF & CEILING FRAME - GALV. STEEL FRAMEWORK
- ROOF CLADDING - SUPERDEK SHEETING - refer colour schedule
- CEILING - PRE-FINISHED PLYWOOD c/w ALUMINIUM CORNICE
- ROOF FLASHINGS & CORNER TRIMS - COLORBOND - refer colour schedule
- DOOR FRAMES - METAL POWDERCOATED FINISH - refer colour schedule

COLOUR SCHEDULE

- ROOF DECKING
- ROOF FLASHING
- EXTERNAL WALLS
- INTERNAL WALLS
- CEILING
- WINDOWS
- EXTERNAL DOOR FRAME
- VINYL
- CUPPID DOOR & SIDES
- CUPPID TOP & SHELVES
- LOGOS
- PERIMETER / BASE CHANNEL

- COLORBOND
- DEEP OCEAN
- PAPER BARK
- SUREMIST
- MIRAGE PEARL
- DEEP OCEAN
- DEEP OCEAN
- SLATE GREY
- SOFT LEMON
- WHITE
- YES
- BLACK OXIDE

THIS DRAWING IS PROTECTED BY COPYRIGHT LAWS © 2007 DO NOT SCALE. REFER TO DIMENSIONS ONLY

REV	DESCRIPTION	DATE	INIT	DATE
A	ISSUED FOR CONSTRUCTION	02-02-10	DD	02-02-10
DD	DRAWN BY:	CHECKED BY:	DATE:	SCALE:
	DD	02-02-10		1:50

HEAD OFFICE
1240 ABERNETHY RD HIGH WYCOMBE W.A. 6057
 Ph: (08) 9281 7500 Fax: (08) 9281 7580
 Email: info@fleetwood.com.au
 INTERSTATE BRANCHES:
 DALGETY RD ALICE SPRINGS N.T. 0870 Ph: 8952 1699 Fax: 8952 1177
 58 MCKINNON RD. BERRIMAH, DARWIN Ph: 8280 5500 Fax: 8280 5511
 N.T. 0820 Ph: 8932 4900 Fax: 8932 4888

CLIENT:
CUMMINGS

LOCATION:
LONSDALE

TITLE:
LUNCHROOM 12.0m x 3.0m - PLAN VIEW

DWG No: B01 - 01 JOB No: SQ05924 REV: A SHEET: A3

